



REAR ELEVATION

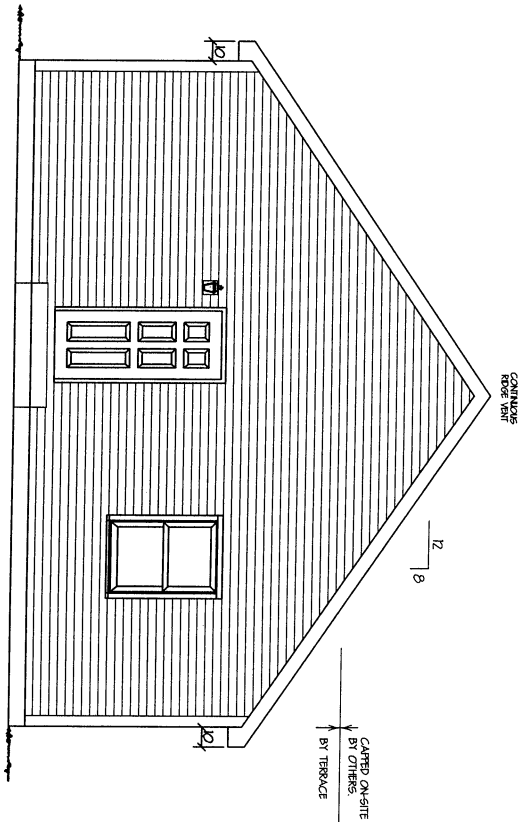

FRONT ELEVATION

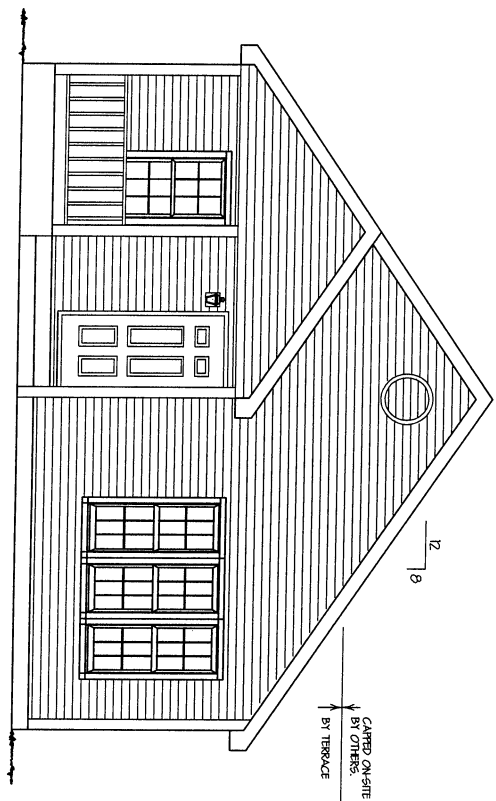

QUOTE # 10275	SERIAL # 10277
BUILDER: MHA	
FILE NAME: UNIT	
MODEL: 28 X 48 RANCH w/ PORCH	
SCALE: 1/8" = 1'-0"	BY: AJC
DATE: 9/14/04	
REVISED: 10/1/04, 8/29/05, X	
X	

Terrace Homes




1553 11th DRIVE
FRIENDSHIP, WISCONSIN 53934


PHONE * (608) 339-7888
FAX * (608) 339-9361

THIS DOCUMENT CONTAINS CONFIDENTIAL OR PROPRIETARY INFORMATION OF TERRACE HOMES MFG. DIV. MANTERNACH DEVELOPMENT CO. INC. NEITHER THIS DOCUMENT NOR THE INFORMATION HEREIN IS TO BE REPRODUCED, DISTRIBUTED, USED OR DISCLOSED EITHER IN WHOLE OR IN PART EXCEPT AS SPECIFICALLY AUTHORIZED BY TERRACE HOMES MFG. DIV. MANTERNACH DEVELOPMENT COMPANY INC.

RIGHT ELEVATION

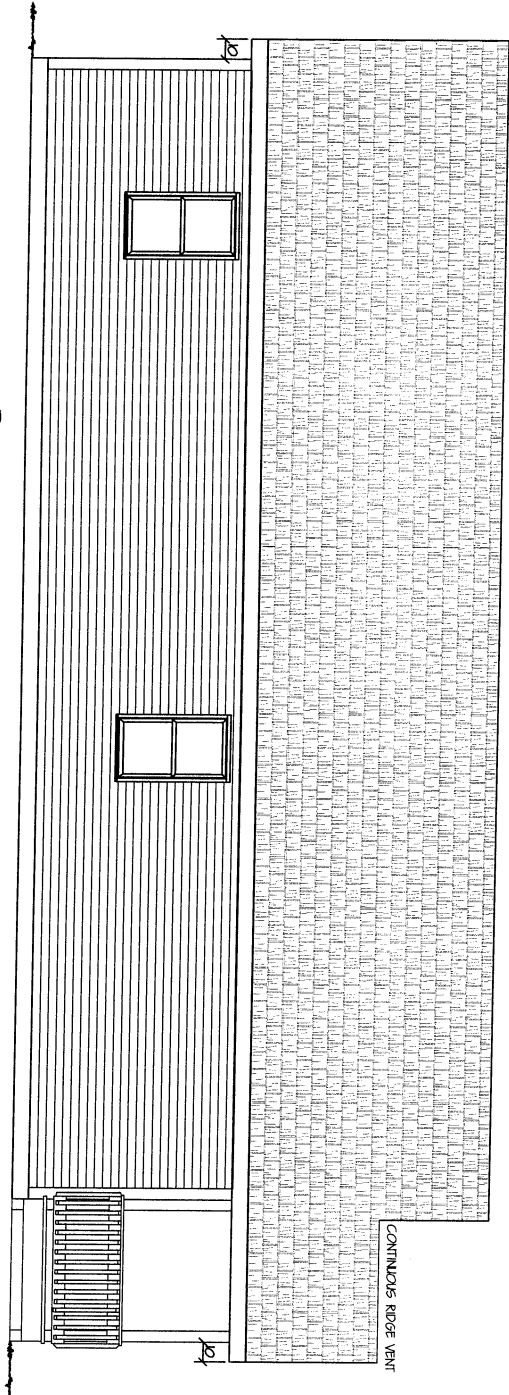

LEFT ELEVATION

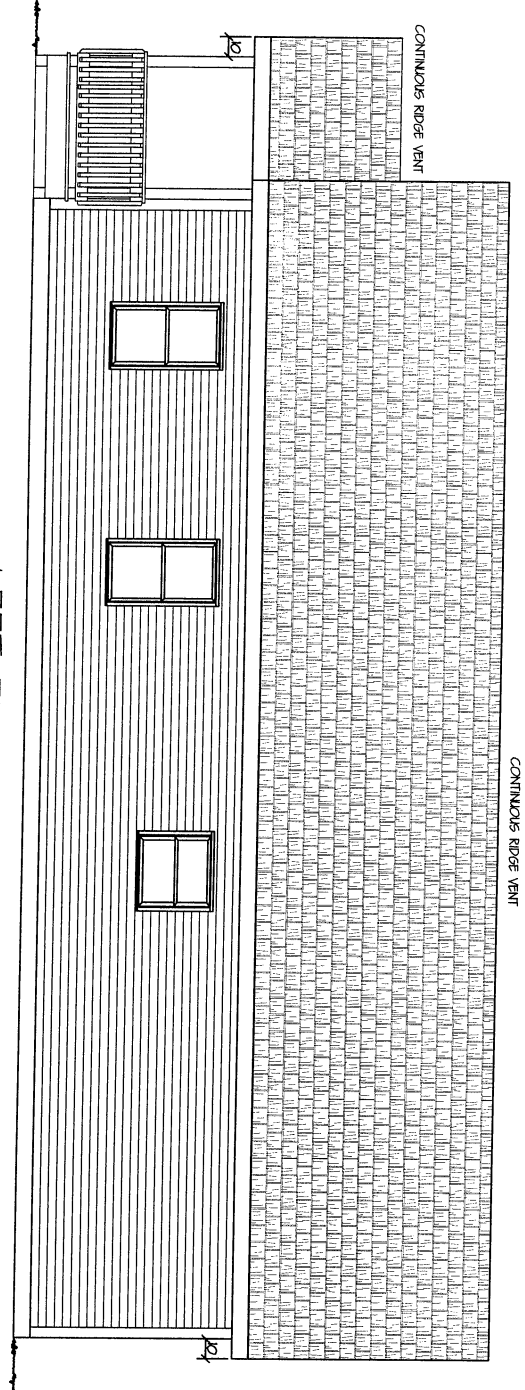


QUOTE # 10275	SERIAL # 10277
BUILDER: MHA	
FILE NAME: UNIT	
MODEL: 28 X 48 RANCH w/ PORCH	
SCALE: 1/8" = 1'-0"	BY: AJC
DATE: 9/14/04	
REVISED: 10/1/04, 8/29/05, X	
X	

Terrace  Homes
 1553 11th DRIVE
 FRIENDSHIP, WISCONSIN 53934

PHONE * (608) 339-1888
 FAX * (608) 339-9361

THIS DOCUMENT CONTAINS CONFIDENTIAL OR PROPRIETARY INFORMATION OF TERRACE HOMES MFG. DIV. MANTERNACH DEVELOPMENT CO. INC. NEITHER THIS DOCUMENT NOR THE INFORMATION HEREIN IS TO BE REPRODUCED, DISTRIBUTED, USED OR DISCLOSED EITHER IN WHOLE OR IN PART EXCEPT AS SPECIFICALLY AUTHORIZED BY TERRACE HOMES MFG. DIV. MANTERNACH DEVELOPMENT COMPANY INC.

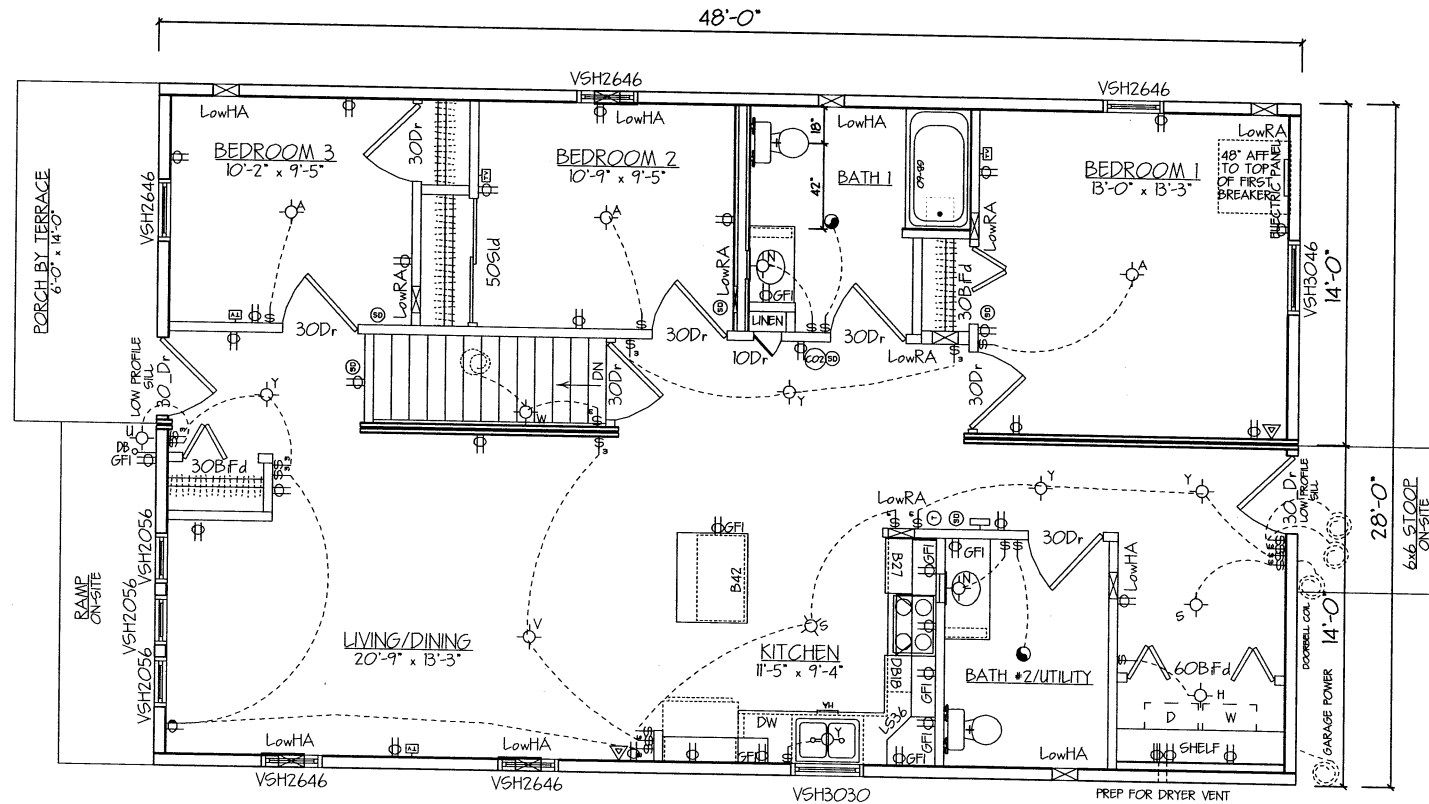

NOTE: ALL RECEPTS 27" AFF TO CENTER OF BOX.

OPENING SCHEDULE							LEVEL A
NAME	TYPE	QTY.	WIDTH	HEIGHT	DESCRIPTION		
VSH2056	WINDOW	3	2'-1/2"	5'-6 1/2"	Vnyl 2056 S.H.		
VSH2646	WINDOW	5	2'-6 1/2"	4'-6 1/2"	Vnyl 2646 S.H.		
VSH3030	WINDOW	1	3'-1/2"	3'-1/2"	Vnyl 3030 S.H.		
VSH3046	WINDOW	1	3'-1/2"	4'-6 1/2"	Vnyl 3046 S.H.		

FLOOR PLAN

NOTE: ALL SMOKE DETECTORS 110V W/ BATTERY BACK-UP & INTERCONNECTED. DROP WIRE FOR BASEMENT SP.
 NOTE: ELECTRICAL & HOT/RETURN AIR LAYOUT SHOWN AS SUGGESTED PLACEMENT ONLY. ACTUAL LAYOUT MAY VARY DUE TO PLACEMENT OF M&C. STRUCTURAL MEMBERS.


LIGHT FIXTURE SCHEDULE		
QTY.	MARK	MFG. #
3	A	7596-02
	B	H41CAT
	C	H7ICAT
	D	42OW
	E	42OPB
	F	31ZW
	G	170PS
1	H	4971-15
	J	GLOBE
	K	TRACK
	L	FEED
	M	40026-05
2	N	40024-05
	O	5445E
	P	5245E
	Q	12555205
	R	330205
2	S	5328-15
	T	UCL20MM (PUCK)
1	U	88B-12
1	V	31036-777
1	W	41036-777
	X	51035-777
5	Y	5326-15
	Z	51075-777
	AA	8607-12
	BB	786L
	UU	1105
	VV	1156-14
1		200 AMP
		40 CIRCUIT

QUOTE # 10275 SERIAL # 10271
 BUILDER: MHA
 FILE NAME: UNIT #?
 MODEL: 28 X 48 RANCH w/ PORCH
 SCALE: 1/8" = 1'-0" BY: AJC
 DATE: 9/14/04
 REVISED: 10/1/04, 8/27/05, X

Terrace Homes
 1553 11th DRIVE
 FRIENDSHIP, WISCONSIN 53934

PHONE * (608) 339-7888
 FAX * (608) 339-9361

THIS DOCUMENT CONTAINS CONFIDENTIAL OR PROPRIETARY INFORMATION OF TERRACE HOMES MFG. DIV. MANITERNACH DEVELOPMENT CO. INC. NEITHER THIS DOCUMENT NOR THE INFORMATION HEREIN IS TO BE REPRODUCED, DISTRIBUTED, USED OR DISCLOSED EITHER IN WHOLE OR IN PART EXCEPT AS SPECIFICALLY AUTHORIZED BY TERRACE HOMES MFG. DIV. MANITERNACH DEVELOPMENT COMPANY INC.



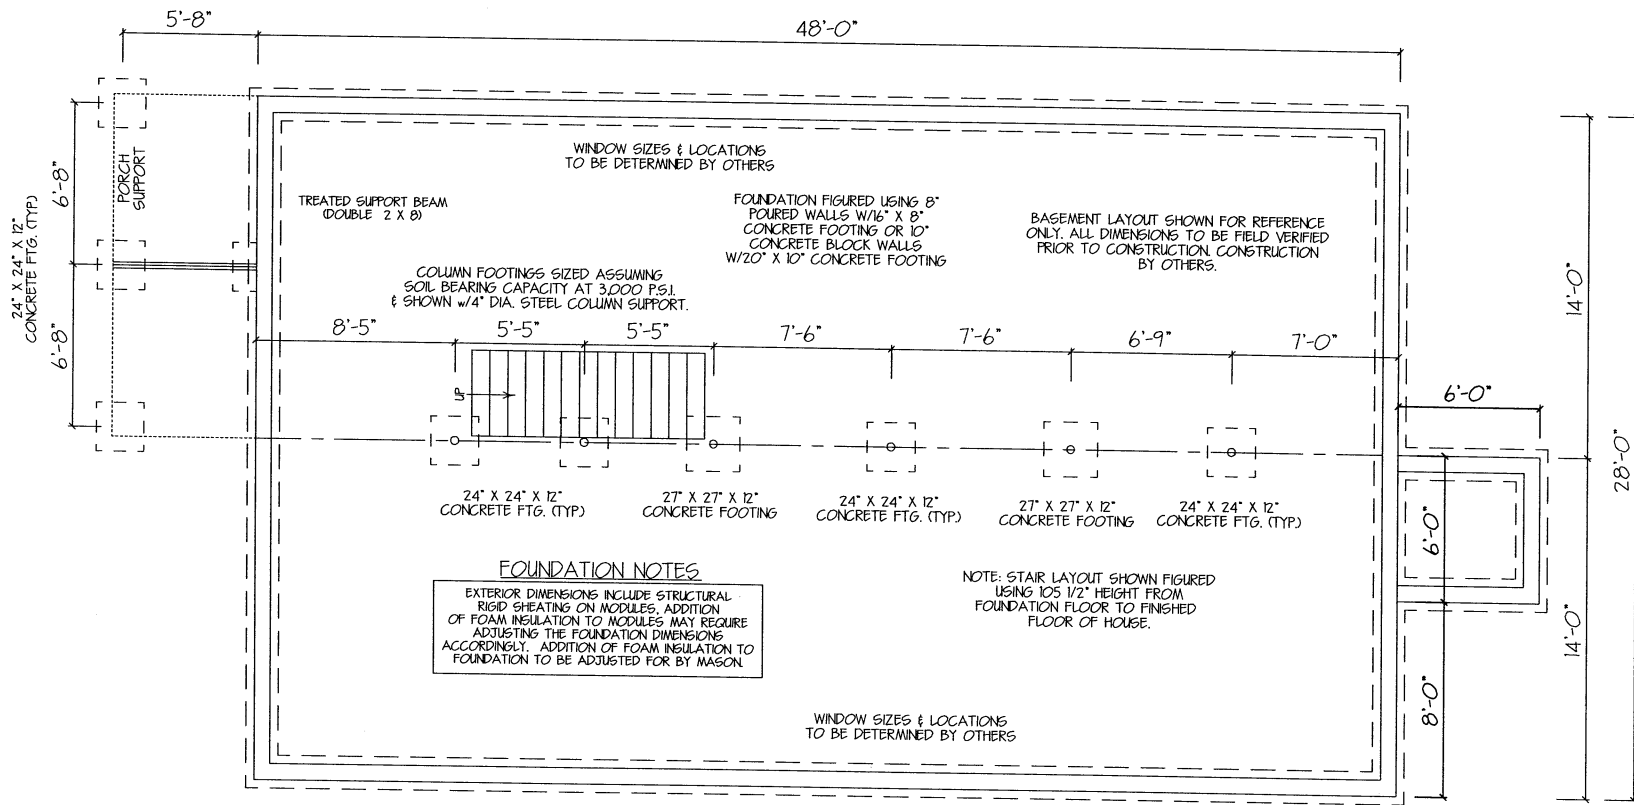


FOUNDATION NOTES

EXTERIOR DIMENSIONS INCLUDE STRUCTURAL RIGID SHEATHING ON MODULES. ADDITION OF FOAM INSULATION TO MODULES MAY REQUIRE ADJUSTING THE FOUNDATION DIMENSIONS ACCORDINGLY. ADDITION OF FOAM INSULATION TO FOUNDATION TO BE ADJUSTED FOR BY MASON.

NOTE: STAIR LAYOUT SHOWN FIGURED USING 105 1/2" HEIGHT FROM FOUNDATION FLOOR TO FINISHED FLOOR OF HOUSE.

WINDOW SIZES & LOCATIONS TO BE DETERMINED BY OTHERS

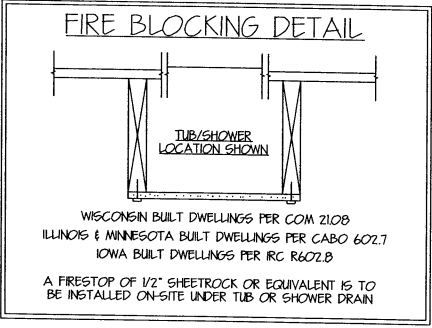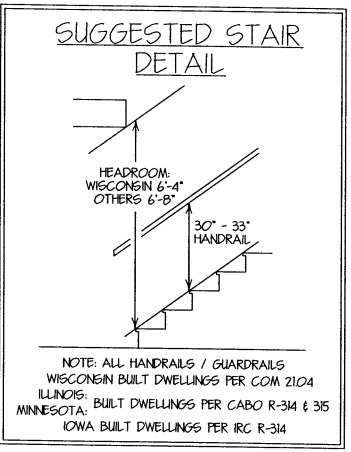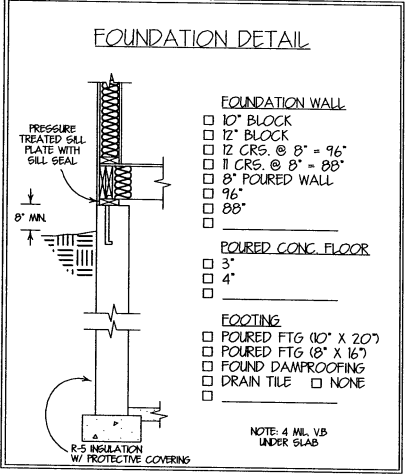

FOUNDATION

EXTERIOR DIMENSIONS INCLUDE STRUCTURAL RIGID SHEATHING ON MODULES. ADDITION OF FOAM INSULATION TO MODULES MAY REQUIRE ADJUSTING THE FOUNDATION DIMENSIONS ACCORDINGLY. ADDITION OF FOAM INSULATION TO FOUNDATION TO BE ADJUSTED FOR BY MASON. ADDITION OF BRICK TO HOME WILL REQUIRE A 4" BRICK LEDGE FOR SUPPORT. MASON TO VERIFY LOCATIONS.

THIS DOCUMENT CONTAINS CONFIDENTIAL OR PROPRIETARY INFORMATION OF TERRACE HOMES MFG. DIV. MANITERNACH DEVELOPMENT CO. INC. NEITHER THIS DOCUMENT NOR THE INFORMATION HEREIN IS TO BE REPRODUCED, DISTRIBUTED, USED OR DISCLOSED EITHER IN WHOLE OR IN PART EXCEPT AS SPECIFICALLY AUTHORIZED BY TERRACE HOMES MFG. DIV. MANITERNACH DEVELOPMENT COMPANY INC.

Terrace Homes

PHONE * (608) 339-7888
FAX * (608) 339-9361

1553 14th DRIVE
FRIENDSHIP, WISCONSIN 53934

QUOTE # 10275	SERIAL # 10277
BUILDER: MHA	
FILE NAME: UNIT	
MODEL: 28 X 48 RANCH w/ PORCH	
SCALE: 1/8" = 1'-0"	BY: AJC
DATE: 9/14/04	
REVISED: 10/10/04, 8/29/05, X	