



FRONT ELEVATION

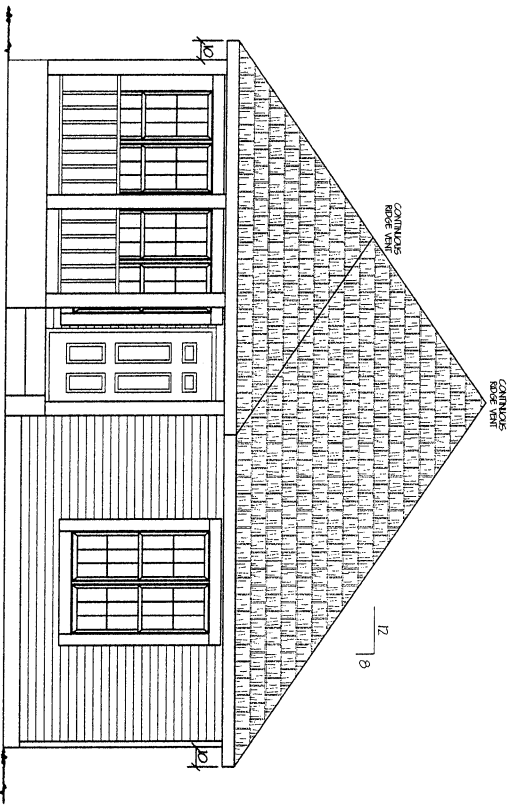

REAR ELEVATION

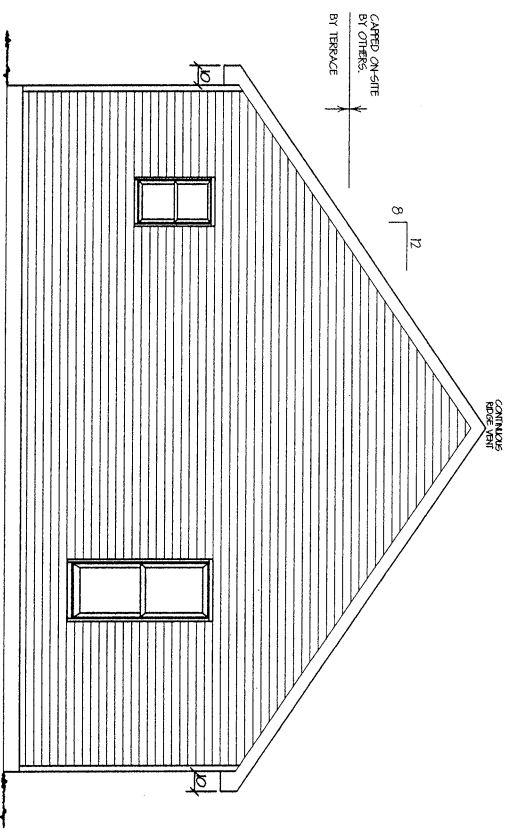


|                                     |            |
|-------------------------------------|------------|
| QUOTE # 10012                       | SERIAL # Y |
| BUILDER: MILWAUKEE HOUSING AUTH     |            |
| FILE NAME: MHA                      |            |
| MODEL: 2954/58 LAUREL               |            |
| SCALE: 1/8" = 1'-0"                 | BY: BAF    |
| DATE: 4/27/04                       |            |
| REVISED: 5-20-04 BEM, 8/4/04 AJC, X |            |
| X                                   |            |



**Terrace Homes**  
 1553 11th DRIVE FRIENDSHIP, WISCONSIN 53934  
 PHONE \* (608) 339-7888 FAX \* (608) 339-9361

THIS DOCUMENT CONTAINS CONFIDENTIAL OR PROPRIETARY INFORMATION OF TERRACE HOMES MFG. DIV. MANTERNACH DEVELOPMENT CO. INC. NEITHER THIS DOCUMENT NOR THE INFORMATION HEREIN IS TO BE REPRODUCED, DISTRIBUTED, USED OR DISCLOSED EITHER IN WHOLE OR IN PART EXCEPT AS SPECIFICALLY AUTHORIZED BY TERRACE HOMES MFG. DIV. MANTERNACH DEVELOPMENT COMPANY INC.

RIGHT ELEVATION

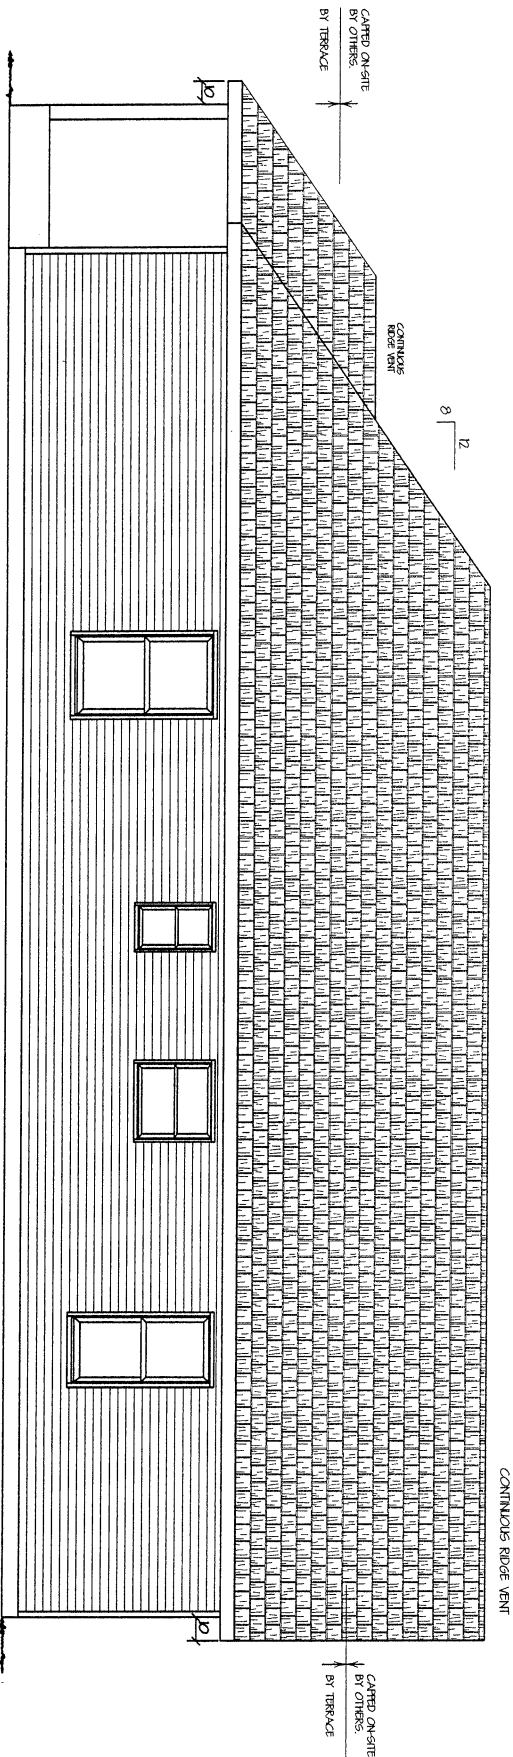

LEFT ELEVATION

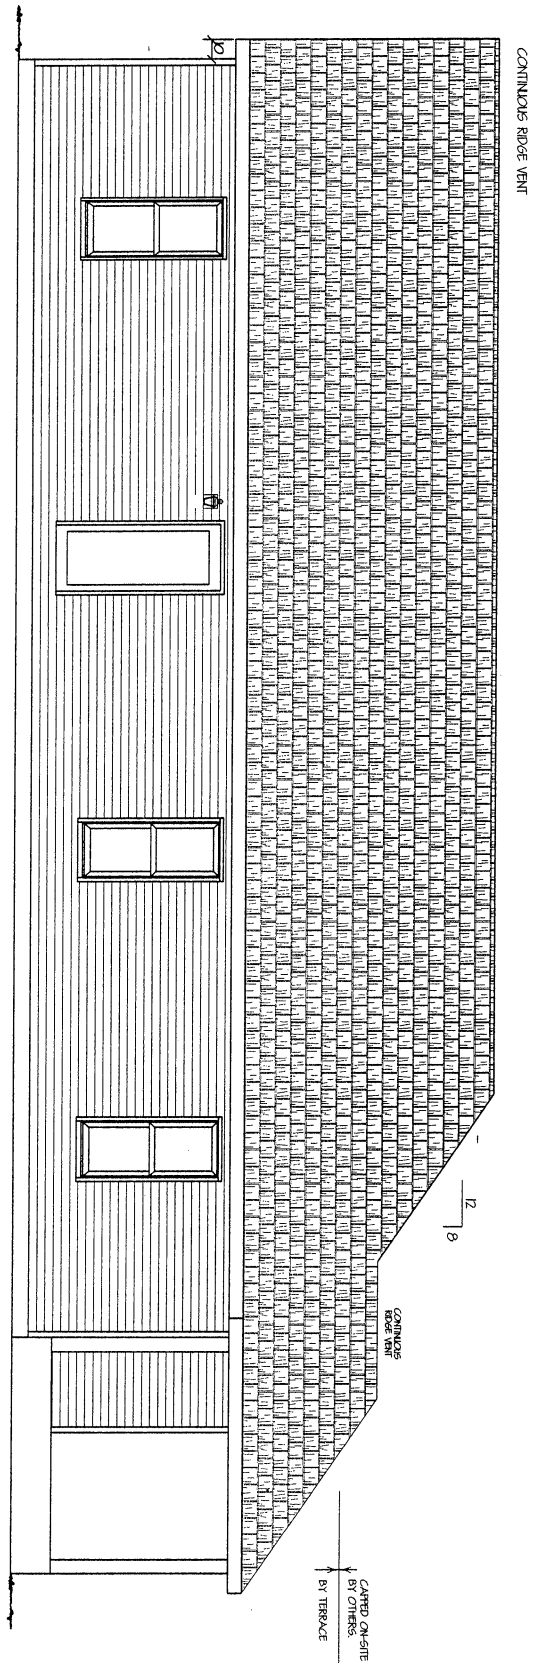

|                                     |            |
|-------------------------------------|------------|
| QUOTE # 10012                       | SERIAL # Y |
| BUILDER: MILWAUKEE HOUSING AUTH     |            |
| FILE NAME: MHA                      |            |
| MODEL: 2954/58 LAUREL               |            |
| SCALE: 1/8" = 1'-0"                 | BY: BAF    |
| DATE: 4/27/04                       |            |
| REVISED: 5-20-04 BEM, 8/4/04 AJC, X |            |
| X                                   |            |


Terrace Homes

1553 11th DRIVE  
FRIENDSHIP, WISCONSIN 53934



PHONE \* (608) 339-7888  
FAX \* (608) 339-9361

THIS DOCUMENT CONTAINS CONFIDENTIAL OR PROPRIETARY INFORMATION OF TERRACE HOMES MFG. DIV. MANTERNACH DEVELOPMENT CO. INC. NEITHER THIS DOCUMENT NOR THE INFORMATION HEREIN IS TO BE REPRODUCED, DISTRIBUTED, USED OR DISCLOSED EITHER IN WHOLE OR IN PART EXCEPT AS SPECIFICALLY AUTHORIZED BY TERRACE HOMES MFG. DIV. MANTERNACH DEVELOPMENT COMPANY INC.

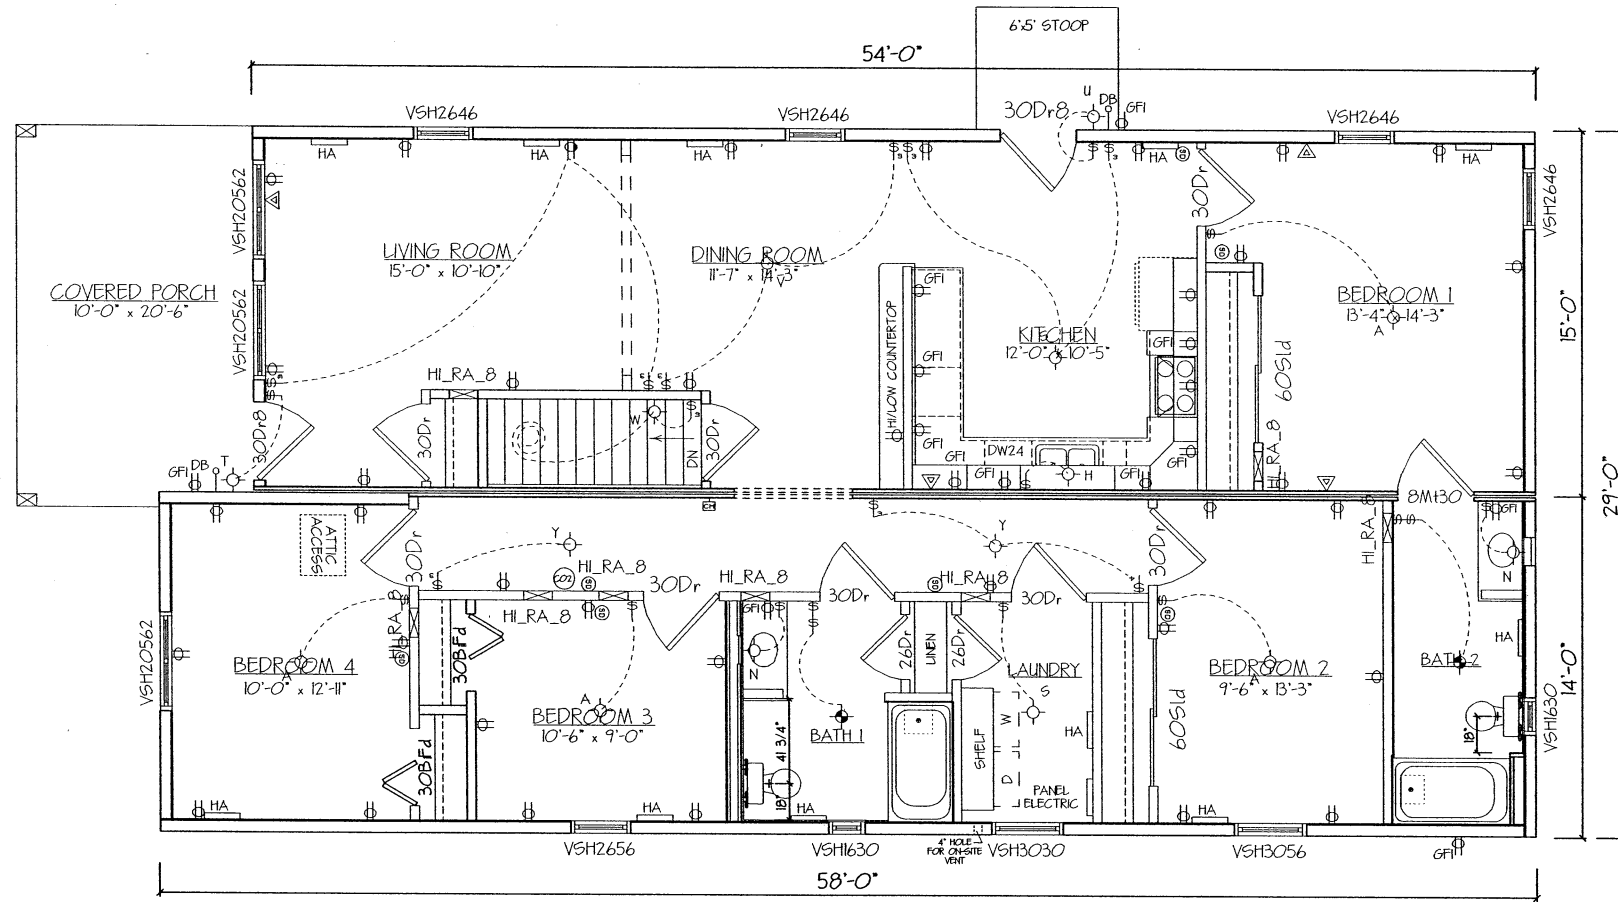

LIGHT FIXTURE SCHEDULE

| QTY. | MARK | MFG. #         |
|------|------|----------------|
| 4    | A    | 7596-02        |
|      | B    | H47ICTAT       |
|      | C    | H7ICAT         |
|      | D    | 78P            |
|      | E    | 704PB          |
|      | F    | 312W           |
|      | G    | 170PS          |
| 1    | H    | 4971-15        |
|      | J    | GLOBE          |
|      | K    | TRACK          |
|      | L    | FEED           |
|      | M    | 40026-05       |
| 2    | N    | 40024-05       |
|      | O    | 5445E          |
|      | P    | 5245E          |
|      | Q    | 12555205       |
|      | R    | 330205         |
| 2    | S    | 5328-15        |
| 1    | T    | 8815-12        |
| 1    | U    | 8813-12        |
| 1    | V    | 31036-777      |
| 1    | W    | 41036-777      |
|      | X    | 51035-777      |
| 2    | Y    | 5326-15        |
|      | Z    | 51075-777      |
|      | AA   | UGL20WH (PICK) |
|      | BB   | 8607-12        |
|      | UU   | 1105           |
|      | VV   | 1156-14        |
| 1    |      | 200 AMP        |
|      |      | 30 CIRCUIT     |

RIGHT   
LEFT

**FLOOR PLAN**

NOTE: ALL SMOKE DETECTORS 110V W/  
BATTERY BACK-UP & INTERCONNECTED.  
DROP WIRE FOR BASEMENT 5D.  
NOTE: ELECTRICAL & HOT/RETURN AIR  
LAYOUT SHOWN AS SUGGESTED  
PLACEMENT ONLY. ACTUAL LAYOUT  
MAY VARY DUE TO PLACEMENT OF  
M&C. STRUCTURAL MEMBERS.

THE LAUREL

OPENING SCHEDULE

| NAME     | TYPE   | QTY. | WIDTH     | HEIGHT    | DESCRIPTION            | LEVEL A |
|----------|--------|------|-----------|-----------|------------------------|---------|
| VSH1630  | WINDOW | 2    | 1'-6 1/2" | 3'-1/2"   | Vinyl 1630 Single Hung |         |
| VSH20562 | WINDOW | 3    | 4'-1/2"   | 5'-6 1/2" | Vinyl 2056 SH. Mull    |         |
| VSH2646  | WINDOW | 4    | 2'-6"     | 4'-6 1/2" | Vinyl 2646 Single Hung |         |
| VSH2656  | WINDOW | 1    | 2'-6"     | 5'-6 1/2" | Vinyl 2656 Single Hung |         |
| VSH3030  | WINDOW | 1    | 3'-1/2"   | 3'-1/2"   | Vinyl 3030 Single Hung |         |
| VSH3056  | WINDOW | 1    | 3'-1/2"   | 5'-6 1/2" | Vinyl 3056 Single Hung |         |


THIS DOCUMENT CONTAINS CONFIDENTIAL OR  
 PROPRIETARY INFORMATION OF TERRACE HOMES  
 MFG. DIV. MANTERVACH DEVELOPMENT CO. INC.  
 NO OTHER DIV. OF MANTERVACH DEVELOPMENT CO. INC.  
 HEREIN IS TO BE REPRODUCED OR THE INFORMATION  
 HEREIN IS TO BE REPRODUCED EITHER IN WHOLE OR IN  
 PART OR DISCLOSED TO ANY OTHER PARTY WITHOUT THE  
 WRITTEN PERMISSION OF TERRACE HOMES MFG. DIV. MANTERVACH  
 DEVELOPMENT COMPANY INC.

Terrace Homes

PHONE \* (608) 339-7888  
FAX \* (608) 339-9361

1553 11th DRIVE  
FRIENDSHIP, WISCONSIN 53934

|            |                            |          |     |
|------------|----------------------------|----------|-----|
| QUOTE #    | 1002                       | SERIAL # | Y   |
| BUILDER:   | MILWAUKEE HOUSING AUTH     |          |     |
| FILE NAME: | MFA                        |          |     |
| MODEL:     | 2954/58 LAUREL             |          |     |
| SCALE:     | 1/8" = 1'-0"               | BY:      | BAF |
| DATE:      | 4/27/04                    |          |     |
| REVISED:   | 5-20-04 BEH. 8/4/04 AJC. X |          |     |

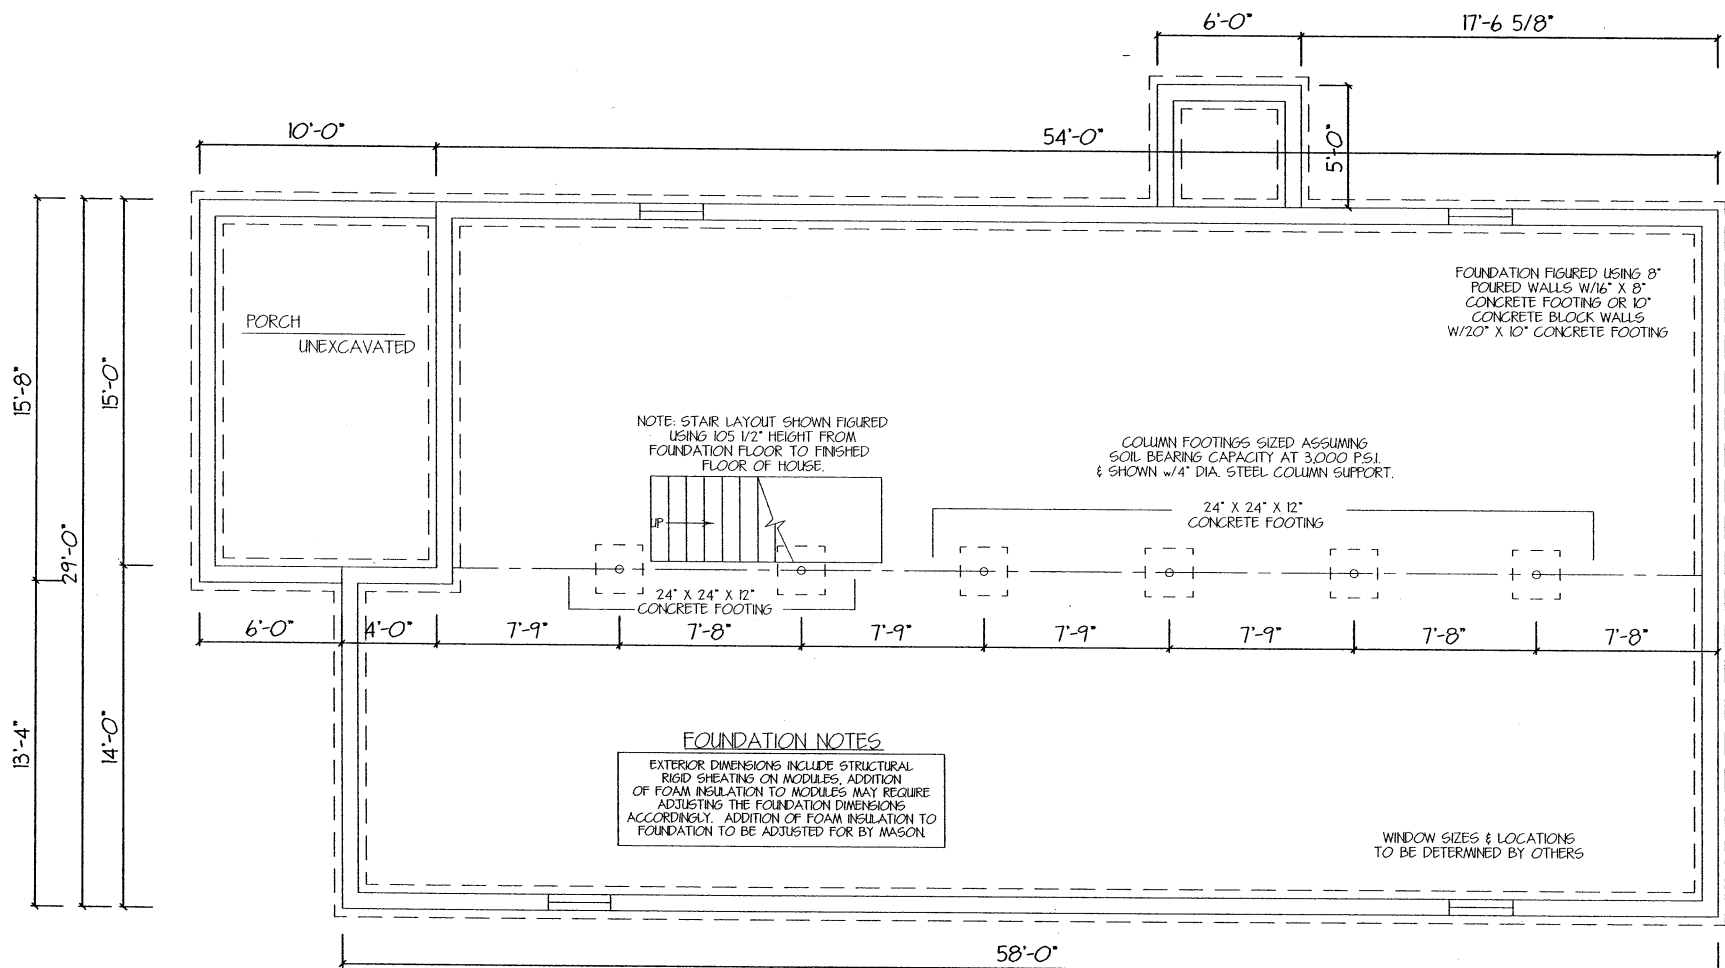

NOTE: STAIR LAYOUT SHOWN FIGURED USING 105 1/2" HEIGHT FROM FOUNDATION FLOOR TO FINISHED FLOOR OF HOUSE.




COLUMN FOOTINGS SIZED ASSUMING SOIL BEARING CAPACITY AT 3,000 P.S.I. & SHOWN w/4" DIA. STEEL COLUMN SUPPORT.

FOUNDATION FIGURED USING 8" POURED WALLS W/16" X 8" CONCRETE FOOTING OR 10" CONCRETE BLOCK WALLS W/20" X 10" CONCRETE FOOTING

**FOUNDATION NOTES**  
 EXTERIOR DIMENSIONS INCLUDE STRUCTURAL RIGID SHEATHING ON MODULES. ADDITION OF FOAM INSULATION TO MODULES MAY REQUIRE ADJUSTING THE FOUNDATION DIMENSIONS ACCORDINGLY. ADDITION OF FOAM INSULATION TO FOUNDATION TO BE ADJUSTED FOR BY MASON.

WINDOW SIZES & LOCATIONS TO BE DETERMINED BY OTHERS

**FOUNDATION**  
 EXTERIOR DIMENSIONS INCLUDE STRUCTURAL RIGID SHEATHING ON MODULES. ADDITION OF FOAM INSULATION TO MODULES MAY REQUIRE ADJUSTING THE FOUNDATION DIMENSIONS ACCORDINGLY. ADDITION OF FOAM INSULATION TO FOUNDATION TO BE ADJUSTED FOR BY MASON. ADDITION OF BRICK TO HOME WILL REQUIRE A 4" BRICK LEDGE FOR SUPPORT. MASON TO VERIFY LOCATIONS.

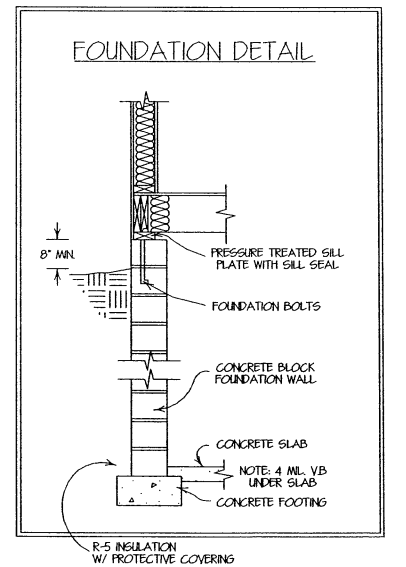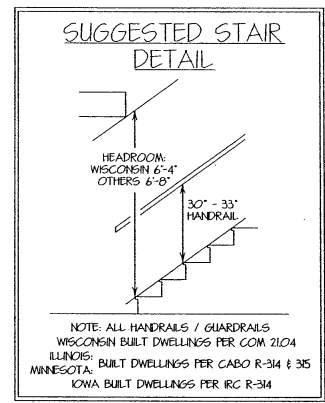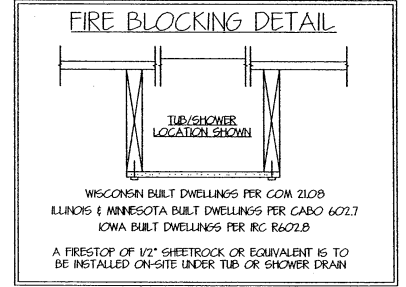

THIS DOCUMENT CONTAINS CONFIDENTIAL OR PROPRIETARY INFORMATION OF TERRACE HOMES MFG. DIV. MANITERNACH DEVELOPMENT CO. INC. NEITHER THIS DOCUMENT NOR THE INFORMATION HEREIN IS TO BE REPRODUCED, DISTRIBUTED, USED OR DISCLOSED EITHER IN WHOLE OR IN PART EXCEPT AS SPECIFICALLY AUTHORIZED BY TERRACE HOMES MFG. DIV. MANITERNACH DEVELOPMENT COMPANY INC.

**Terrace Homes**

PHONE \* (608) 337-7888  
 FAX \* (608) 337-9361

1553 11th DRIVE  
 FRIENDSHIP, WISCONSIN 53934

QUOTE \* 10012 SERIAL \* Y  
 BUILDER: MILWAUKEE HOUSING AUTH  
 FILE NAME: MHA  
 MODEL: 2954/58 LAUREL  
 SCALE: 1/8" = 1'-0" BY: BAF  
 DATE: 4/27/04  
 REVISED: 5-20-04 BEAM, 8/4/04 AJC, X  
 X